

GENERAL NOTES:

- ALL DUCTWORK SERVING FANS (EXCEPT DRYER EXHAUST DUCTWORK) AND/OR HVAC UNITS ON ROOF OR MEW ARE TO BE ACoustically LINED ON THAT FLOOR.
- PROVIDE 2 HR FIRE WRAP AS INDICATED.
- MAU-15-1 & MAU-15-2

- OUTSIDE AIR INTAKE DUCT - 10 FEET OF INTERNAL LINING FROM UNIT
- 15 FEET INTERNAL LINING ON SUPPLY

DIESEL PARTICULATE FILTER (DPF) NOTES:

(8) 12" DIAMETER X 12" LONG CATALYZED, WALL-FLOW, PASSIVE DIESEL PARTICULATE FILTER ELEMENTS ALL ARRANGED IN A (2) HIGH X (4) WIDE ARRAY DESIGNED FOR USE ONLY ON AN MTU/ON SITE ENERGY 16V2000 1250KW GENERATOR (PROVIDED BY ALTERNATE POWER GENERATION CONTACT ZACH NEWROFF 808-963-1374) RUNNING AT FULL LOAD. ENGINE EXHAUST IS DIRECTED ACROSS THESE DPF ELEMENTS WITHIN A CUSTOM BUILT 304 SERIES STAINLESS STEEL HOUSING. THE OVERALL HOUSING SIZE CANNOT EXCEED LARGER THAN 80"0" LONG, 80"0" WIDE, AND 36"50" TALL. THIS HOUSING MUST INCORPORATE AN INTERNALLY INSULATED SILENCER SECTION TO ACHIEVE CRITICAL GRADE SOUND ATTENUATION OF 25-32DB(A) AT A BACKPRESSURE NO GREATER THAN 60% OF THE ENGINE MANUFACTURERS MAXIMUM ALLOWABLE BACKPRESSURE.

THE CATALYZED DPF ELEMENTS ESSENTIALLY FILTER OUT UNBURNED CARBON PARTICLES OR SOOT, THAT OCCURS IN THE DIESEL ENGINE EXHAUST, ESPECIALLY UNDER COLD START UP CONDITIONS. THE DPF'S WILL CAPTURE 95%+ OF THESE CARBON PARTICLES, OF A SPECIFIED SIZE, TO THEIR OVERALL CAPACITY. THESE CARBON PARTICLES, OR OFTEN CALLED PARTICULATE MATTER (PM), NEED TO BE REMOVED FROM THE DPF'S. THIS IS ACCOMPLISHED BY THE CATALYZED COATING ON THE DPF ELEMENTS REACHING A "LIGHT OFF" TEMPERATURE, DRIVEN BY THE EXHAUST GAS TEMPERATURE. ONCE THIS LIGHT OFF TEMPERATURE IS ACHIEVED, THE DPF WILL OPERATE IN A CONDITION CALLED CONTINUOUS REGENERATION. CONTINUOUS REGENERATION WILL BURN OFF THE CARBON PARTICLES TRAPPED WITHIN THE DPF ELEMENTS AS LONG AS THE LIGHT OFF TEMPERATURE IS SUSTAINED.

CARBON PARTICLES WILL BUILD UP IN THE DPF ELEMENTS AND WILL INCREASE BACKPRESSURE IN THE EXHAUST. TO HELP MANAGE THIS, A DIFFERENTIAL PRESSURE SWITCH AND MONITORING DEVICE IS RECOMMENDED TO BE UTILIZED IN A PASSIVE DPF SYSTEM TO ALERT THE OPERATOR, OR TO TRIGGER AN ALARM IF A SPECIFIED LIMIT OF BACK PRESSURE HAS BEEN REACHED. WHEN THAT OCCURS, SUFFICIENT LOAD MUST BE APPLIED TO THE ENGINE IN ORDER TO REACH AND MAINTAIN THE LIGHT OFF TEMPERATURE OF THE DPF'S.

EXHIBIT DRAWING NO: 15

EXISTING MECHANICAL EQUIPMENT DIAGRAM

15TH FLOOR

11-06-2019

LEGEND

	EQUIPMENT
	REQUIRED CLEARANCES
	FDNY ACCESS
	ELECTRICAL
	CIRCULATION
	WHITE SPACE

15TH FLOOR AREA CALCULATIONS

MECHANICAL EQUIPMENT	509 SF
REQUIRED CLEARANCES	358.5 SF
FDNY ACCESS	389 SF
ELECTRICAL	2,933 SF
CIRCULATION	2,457 SF
WHITE SPACE	14,151.5 SF
TOTAL FLOOR AREA	20,478 SF

TOTAL ALLOWABLE DEDUCTIONS
MECHANICAL/ ELECTRICAL

509 + 358.5 + 2,933 = 3,800.5 SF

PERCENTAGE OF FLOOR AREA

3,800.5 / 20,478 = 18%

WEST 66TH STREET
36 WEST 66TH STREET, NEW YORK, NY

OWNER/DEVELOPER:
West 66th Investor, LLC
c/o Paul Hastings, LLP

75 EAST 55TH STREET
NEW YORK, NY 10022
T: 212.318.6618
F: 212.318.6002

EXECUTIVE ARCHITECT:

SLCEArchitects, LLP
1359 BROADWAY NEW
YORK, NY 10018 TEL:
(212) 979-8400 FAX:
(212) 979-8387

DESIGN ARCHITECT:

80 PINE STREET, 10TH FLOOR
NEW YORK, NY 10005
TEL: (646) 383-4762

STRUCTURAL ENGINEER:

McNAMARA . SALVIA
62 West 45th Street, 11th Floor
New York, NY 10036
McNAMARA . SALVIA Tel (212) 246.9800

MEP ENGINEER:

ICOR CONSULTING
ENGINEERS
485C ROUTE 1 SOUTH, SUITE 200
SEELIN, NJ 08830
TEL: 908.272.3300
FAX: 908.272.4440

GEOTECHNICAL ENGINEER:

Langan Engineering
River Drive Center 1
619 River Drive
Briarwood Park, NJ 07407
TEL: (201) 794.6000
FAX: (201) 794.0366

FACADE CONSULTANT:

Heintges & Associates
440 Park Avenue South, 15th Fl
New York, NY 10016
TEL: (212) 652.9966

FACADE MAINTENANCE:

ENTER
ENGINEERING LLC
CONSULTING ENGINEERS
166 Ames Street, Hackensack, NJ 07601
Ph: (201) 820-2801 Fax: (201) 820-2804

ELEVATOR CONSULTANT:

Delivering Vertical Transportation
Solutions... Worldwide
vda
Phone: 973-694-6232 Fax: 973-694-2533
e-mail: info@vda-elevator.com

INTERIOR DESIGNER:

SHAMIR SHAH DESIGN
27 West 24th Street, Suite 604
New York, NY 10010
TEL: (212) 274-7576

INTERIOR DESIGNER:

AB CONCEPT
311 P. GLOBAL GATEWAY TOWER,
63 WING HONG STREET
KOWLOON, HONG KONG
TEL: (852) 2525-2468

POOL CONSULTANT:

POOL DESIGN
A Division of Lethrop Associates LLP
333 WESTCHESTER AVENUE
WHITE PLAINS, NY 10604
TEL: (917) 741-1115

LIGHTING DESIGNER:

FOCUS LIGHTING
221 West 16th Street
New York, NY 10026
TEL: (212) 865-1565

LIGHTING DESIGNER:

FILAMENT33 INC
9190 GERMANTOWN AVE
PHILADELPHIA, PA 19118
TEL: (484) 674-0133

AUDIO VISUAL & TELECOMMUNICATIONS:

Carani
404 FIFTH AVENUE, 8TH FL
NEW YORK, NY 10018
TEL: (212) 370-1776


1	26/11/2018	ISSUED TO DDB
1	08/17/2018	80% CDS
1	06/04/2018	CD PROGRESS SET
1	04/04/2018	50% CDS SET
1	03/27/2018	CD PROGRESS SET
1	03/19/2018	CD PROGRESS SET
1	11/15/2017	CD PROGRESS SET
1	11/14/2017	100% DDB
1	06/23/2017	50% CDS SET
1	02/14/2017	100% CD DWGS

NO. 1 Date: Revision:

DDB NUMBER: NB#121190200

NORTH ARROW Scale: 3/16" = 1'-0"

KEY PLAN:

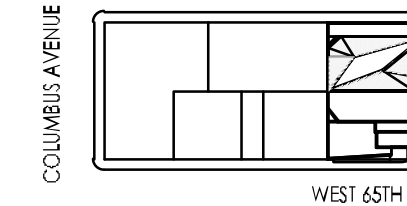

PROJECT:

WEST 66TH STREET
NEW YORK, NEW YORK

DRAWING TITLE:

15TH FLOOR
MECHANICAL HVAC PLAN

SEAL & SIGNATURE:

DATE: 08/12/2018

PROJECT NO: 2015-05

DRAWN BY: MFP

CHECKED BY: V.P.

DRAWING NO: M-216.00

17 OF 80

GENERAL NOTES:

1. ALL DUCTWORK SERVING FANS (EXCEPT DRYER EXHAUST DUCTWORK) AND/OR HVAC UNITS ON ROOF OR MECH ARE TO BE ACoustically LINED ON THAT FLOOR.
2. FURNISH AND INSTALL ALL NEUTRALIZATION TANKS AT BOILER ROOM AND AS REQUIRED BY CODE OR SPECIFICATIONS. PIPING FROM FLUE TO EACH NEUTRALIZATION TANK SHALL BE BY MECHANICAL CONTRACTOR.
3. PROVIDE DRAIN CONNECTION AT THE BOTTOM OF FLUE RISER AS WELL AS DRAIN CONNECTIONS AT EVERY 15 FEET WITH HIGH TEMPERATURE STAINLESS STEEL HOSE PIPE ON THE FLUE'S HORIZONTAL RUN IN BOILER ROOM. CONDENSATE DRAIN PIPES SHALL BE SCHEDULE 80 CPVC. ALL BREAKING CONNECTIONS TO DRAIN SHALL BE PLASTIC HOSE LOOPEED TO CREATE TRAP.

EXHIBIT DRAWING NO: 17

EXISTING MECHANICAL EQUIPMENT DIAGRAM 17TH FLOOR

11-06-2019

LEGEND

- EQUIPMENT
- REQUIRED CLEARANCES
- FDNY ACCESS
- ELECTRICAL
- CIRCULATION
- WHITE SPACE

17TH FLOOR AREA CALCULATIONS

MECHANICAL EQUIPMENT	412.2 SF
REQUIRED CLEARANCES	1,308 SF
FDNY ACCESS	563 SF
ELECTRICAL	372 SF
CIRCULATION	1,171 SF
WHITE SPACE	6,418.8 SF
TOTAL FLOOR AREA	10,216 SF

TOTAL ALLOWABLE DEDUCTIONS MECHANICAL/ ELECTRICAL

412.2 + 1,308 + 372 = 2,092.2 SF

PERCENTAGE OF FLOOR AREA

2,092.2 / 10,216 = 20%

WEST 66TH STREET
36 WEST 66TH STREET, NEW YORK, NY

OWNER/DEVELOPER:

West 66th Investor, LLC
c/o Paul Hastings, LLP

75 EAST 55TH STREET
NEW YORK, NY 10022
T: 212-318-6618
F: 212-318-6002

EXECUTIVE ARCHITECT:

SLCEArchitects, LLP

1359 BROADWAY NEW
YORK, NY 10018 TEL:
(212) 979-8400 FAX:
(212) 979-8387

DESIGN ARCHITECT:

80 PINE STREET 10TH FLOOR
NEW YORK, NY 10005
TEL: (646) 383-4762

STRUCTURAL ENGINEER:

McNAMARA . SALVIA

62 West 45th Street, 11th Floor
New York, NY 10036
McNAMARA . SALVIA Tel: (212) 246-9800

MEP ENGINEER:

ICOR CONSULTING
ENGINEERS

485C ROUTE 1 SOUTH, SUITE 200
SEUN, NJ 08830
TEL: 908-272-3300
FAX: 908-272-4440

GEOTECHNICAL ENGINEER:

Langan Engineering

River Drive Center 1
619 River Drive
Briarwood Park, NJ 07407
TEL: (201) 794-6900
FAX: (201) 794-6366

FACADE CONSULTANT:

Heintges & Associates

440 Park Avenue South, 15th Fl
New York, NY 10016
TEL: (212) 652-9566

FACADE MAINTENANCE:

ENTER

ENGINEERING LLC
CONSULTING ENGINEERS

166 Ames Street, Hackensack, NJ 07601
Ph: (201) 820-2801 Fax: (201) 820-2804

ELEVATOR CONSULTANT:

Delivering Vertical Transportation
Solutions... Worldwide

27 West 24th Street, Suite 604
New York, NY 10010
TEL: (212) 274-7576

INTERIOR DESIGNER:

SHAMIR SHAH DESIGN

311 IF GLOBAL GATEWAY TOWER,
63 WING HONG STREET
KOWLOON, HONG KONG
TEL: (852) 2525-2428

INTERIOR DESIGNER:

AB CONCEPT

333 WESTCHESTER AVENUE
WHITE PLAINS, NY 10604
TEL: (917) 741-1115

POOL CONSULTANT:

POOL DESIGN
A Division of Lathrop Associates LLP

333 WESTCHESTER AVENUE
WHITE PLAINS, NY 10604
TEL: (917) 741-1115

LIGHTING DESIGNER:

FOCUS LIGHTING

221 West 14th Street
New York, NY 10018
TEL: (212) 565-1565

LIGHTING DESIGNER:

FILAMENT33 INC

910 GERMANTOWN AVE
PHILADELPHIA, PA 19118
TEL: (484) 674-0133

AUDIO VISUAL & TELECOMMUNICATIONS:

Carani
404 FIFTH AVENUE, 8TH FL
NEW YORK, NY 10018
TEL: (212) 370-1776

DATE: 08/17/2018

ISSUED TO DOB

08/17/2018 8:00% CD

08/24/2018 CD PROCESS SET

09/04/2018 50% CD SET

04/27/2018 DOB REVIS

05/19/2018 CD PROCESS SET

11/15/2017 DOB REVIS

11/14/2017 100% DO

06/23/2017 50% DO SET

NO: 1 Date: Revision:

DOB NUMBER:

NB#121190200

NORTH ARROW

Scale: 3/16" = 1'-0"

KEY PLAN:

WEST 66TH STREET

PROJECT:

WEST 66TH STREET
NEW YORK, NEW YORK

DRAWING TITLE:

17TH FLOOR
MECHANICAL HVAC PLAN

SEAL & SIGNATURE:

DATE: 08-17-2018

PROJECT NO: 2015-05

DRAWN BY: MFP

CHECKED BY: VJP

DRAWING NO:

M-220.00

DOB NO:

21 OF 80

GENERAL NOTES:

1. ALL DUCTWORK SERVING FANS (EXCEPT DRYER EXHAUST DUCTWORK) AND OR HVAC UNITS ON ROOF OR MER ARE TO BE ACOUSTICALLY LINED ON THAT FLOOR.

EXHIBIT DRAWING NO: 18	
EXISTING MECHANICAL EQUIPMENT DIAGRAM	
18TH FLOOR	11-06-2019

WEST 66TH STREET
36 WEST 66TH STREET, NEW YORK, NY

NER/DEVELOPER:
est 66th Investor, LLC
o Paul Hastings, LLP
AST 55TH STREET
YORK, NY 10022
2 . 318 . 6618
2 . 318 . 6000

EXECUTIVE ARCHITECT:
LCEArchitects, LLP
BROADWAY NEW
X, NY 10018 TEL.: 979-8400 FAX.: 979-8387

DESIGN ARCHITECT:
Alphetta 
 ONE STREET, 10TH FLOOR
 York, NY 10005
 (646) 393-4762

STRUCTURAL ENGINEER:
CNAMARA . SALVIA
 62 West 45th Street, 11th Floor
New York, NY 10036
Tel (212) 246.9800

ENGINEER:
FOR CONSULTING
ENGINEERS
100 ROUTE 1 SOUTH, SUITE 200
LAKELAND, NJ 08830
908 . 272 . 3300
908 . 272 . 4440

TECHNICAL ENGINEER:
Man Engineering
 1000 River Drive Center 1
 River Drive
 Wood Park, NJ 07407
 (201) 794.6900
 : (201) 794-0366

SALE CONSULTANT:
Leintges & Associates
Park Avenue South, 15th Fl
New York, NY 10016
Tel: (212) 652.2966

TRADE MAINTENANCE:
INTEK
ENGINEERING LLC
 CONSULTING ENGINEERS
 16 Ames Street, Hackensack, NJ 07601
 Tel. (201) 820-2801 Fax (201) 820-2804

WATER CONSULTANT:

engjyd Delivering Vertical Transportation Solutions...Worldwide

Phone: 973-994-0220 Fax: 973-994-2533
e-mail: engjyd@uscc.com

INTERIOR DESIGNER:
HAMIR SHAH DESIGN
West 24th Street, Suite 604
New York, NY 10010
Tel: (212) 274-7576

SENIOR DESIGNER:
B CONCEPT
 OF GLOBAL GATEWAY TOWER,
 WING HONG STREET,
 WLOON, HONG KONG

POOL CONSULTANT:
RACE POOL DESIGN
Division of Lothrop Associates LLP

WESTCHESTER AVENUE
TE PLANS, NY 10604
E (917) 741-1115

LIGHTING DESIGNER:
FOCUS LIGHTING

West 116th Street
New York, NY 10026
Tel: (212) 865-1565

PRINTING DESIGNER:

100 GERMANTOWN AVE
 PHILADELPHIA, PA 19118
 TEL: (464) 674-0133

Perami
FIFTH AVENUE, 8TH FL
NEW YORK, NY 10018
T: (212) 370-1776

06/17/2017	ISSUED TO DOB
06/17/2018	50% CD SET
07/13/2018	ISSUED TO DOB
06/04/2018	CD PROGRESS SET
05/04/2018	50% CD SET
04/27/2018	DOB FILING
03/19/2018	CD PROGRESS SET
11/15/2017	DOB FILING
11/14/2017	100% DO
06/23/2017	50% DI SET
Date:	Revision:

B#121190200

ARROW

Scale: $\frac{3}{16}'' = 1' - 0''$

A horizontal scale bar divided into four equal segments, each representing 3 feet. The segments are labeled 0, 1', 2', 4', 6', 8', and 12'. The bar is divided into 16 equal parts, each representing 1 foot. The segments are shaded in alternating black and white.

PLAN:

WEST 66TH STREET

CENTRAL PARK WEST

SUBJECT:

WEST 66TH STREET
NEW YORK, NEW YORK

DRAWING TITLE:
10TH FLOOR


MECHANICAL HVAC PLAN

	DATE: 08-17-2018
	PROJECT No: 2015-05
	DRAWN BY:

CHECKED BY: _____
DRAWING No: M-221 00


 071905
 REGISTERED PROFESSIONAL ENGINEER
 21 OF 78

48 X

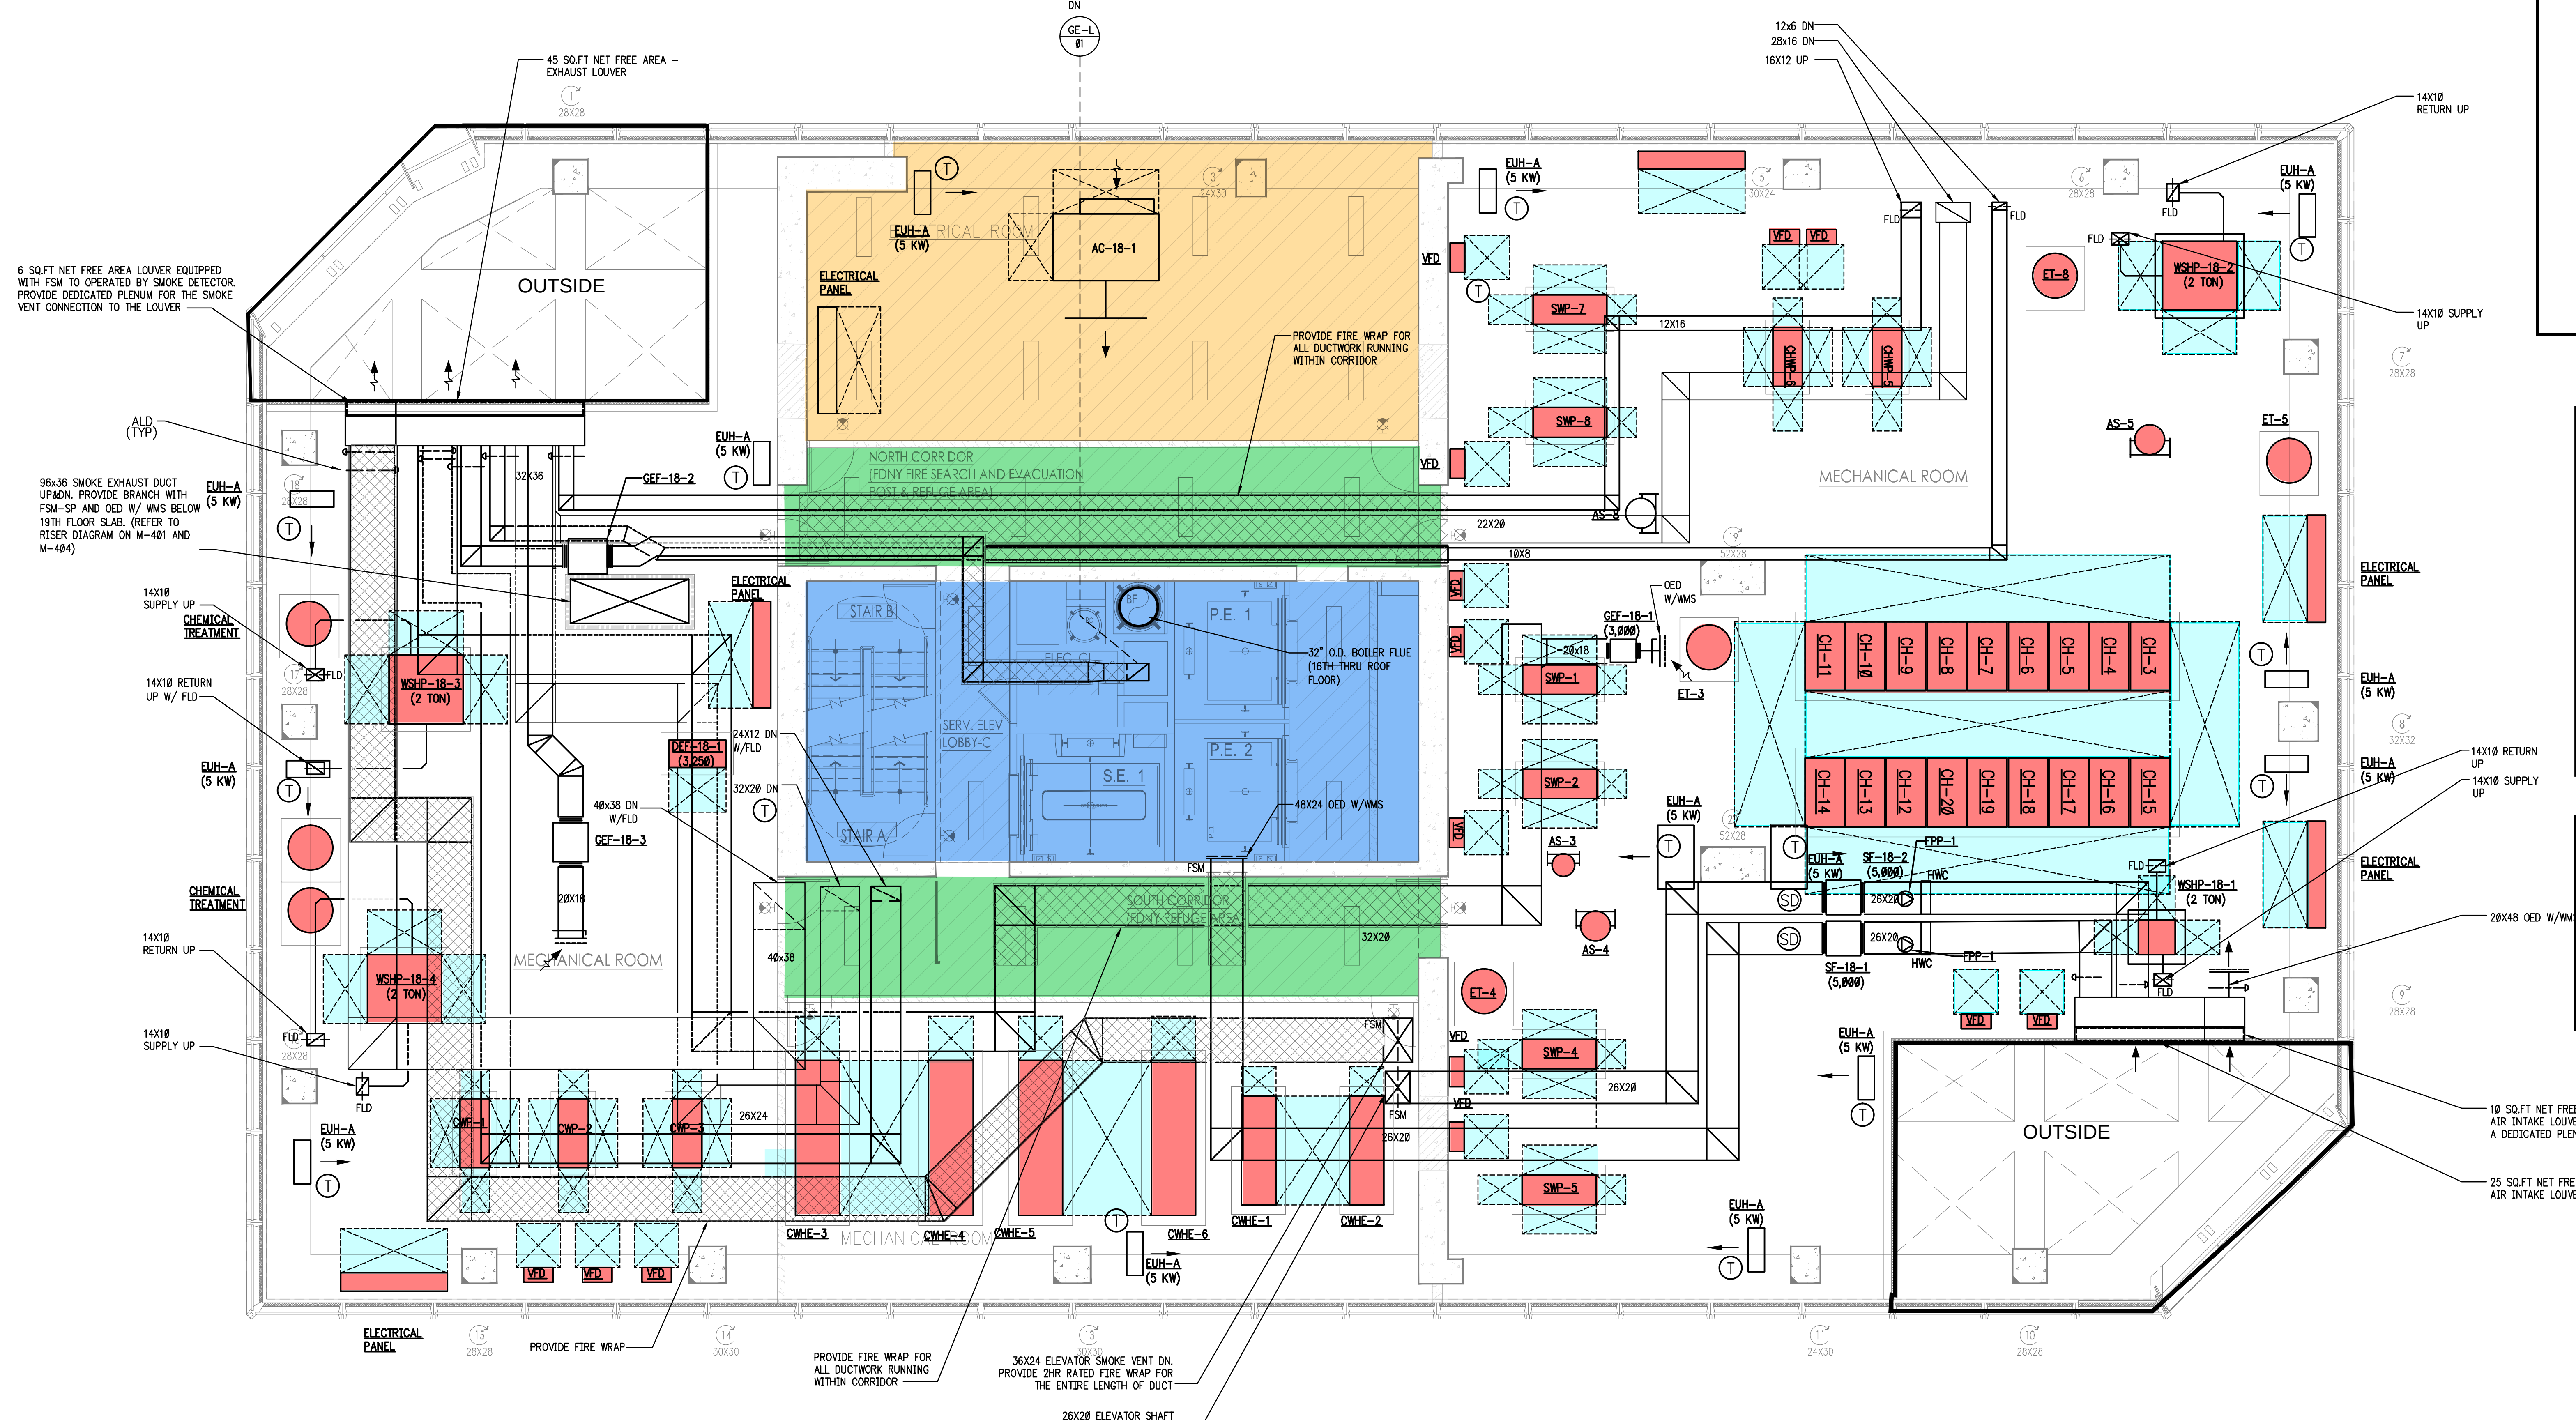

MECHANICAL EQUIPMENT	619.6 SF
REQUIRED CLEARANCES	1,351.9 SF
FDNY ACCESS	678 SF
ELECTRICAL	810 SF
CIRCULATION	782 SF
WHITE SPACE	5,998.5 SF
TOTAL FLOOR AREA	10,240 SF

TOTAL ALLOWABLE DEDUCTIONS MECHANICAL/ ELECTRICAL 619.6 + 1,351.9 + 810 = 2,781.5 SF PERCENTAGE OF FLOOR AREA 2,781.5 / 10,240 = 27%
--

- GENERAL NOTES:
1. ALL DUCTWORK SERVING FANS (EXCEPT DRYER EXHAUST DUCTWORK) AND/OR HVAC UNITS ON ROOF OR MECH ARE TO BE ACOUSTICALLY LINED ON THAT FLOOR.
 2. ALL DUCTWORK SHALL BE PROVIDED WITH 2-HR RATED FIRE WRAP.
 3. MAU-19-1 & MAU-19-2:
 - A. OUTSIDE AIR INTAKE DUCT - PROVIDE 15 FEET OF ACOUSTICAL LINING.
 - B. SUPPLY AIR DUCT - PROVIDE 28 FEET OF ACOUSTICAL LINING.

EXHIBIT DRAWING NO: 19

EXISTING MECHANICAL EQUIPMENT DIAGRAM

19TH FLOOR

11-06-2019

LEGEND

- EQUIPMENT
- REQUIRED CLEARANCES
- FDNY ACCESS
- ELECTRICAL/PLUMBING
- CIRCULATION
- WHITE SPACE

19TH FLOOR AREA CALCULATIONS

MECHANICAL EQUIPMENT	361 SF
REQUIRED CLEARANCES	365.12 SF
FDNY ACCESS	830.5 SF
ELECTRICAL	903.25 SF
PLUMBING	1,393.13 SF
CIRCULATION	960 SF
WHITE SPACE	6,104 SF
TOTAL FLOOR AREA	10,917 SF

TOTAL ALLOWABLE DEDUCTIONS
MECHANICAL/ ELECTRICAL
 $361 + 365.12 + 903.25 + 1,393.13 = 3,022.5$ SF
PERCENTAGE OF FLOOR AREA
 $3,022.5 / 10,917 = 28\%$

19TH FLOOR MECHANICAL HVAC PLAN

SCALE: 3/16" = 1'-0"

19TH FLOOR FDNY ACCESS 7 MECHANICAL HVAC PLAN

SCALE: 3/16" = 1'-0"

WEST 66TH STREET
36 WEST 66TH STREET, NEW YORK, NY

OWNER/DEVELOPER:

West 66th Investor, LLC
c/o Paul Hastings, LLP

75 EAST 55TH STREET
NEW YORK, NY 10022
T: 212-318-6618
F: 212-318-6900

EXECUTIVE ARCHITECT:

SLCEArchitects, LLP

1359 BROADWAY NEW
YORK, NY 10018 TEL:
(212) 979-8400 FAX:
(212) 979-8387

DESIGN ARCHITECT:

80 PINE STREET 10TH FLOOR
NEW YORK, NY 10005
TEL: (646) 383-4762

STRUCTURAL ENGINEER:

McNAMARA . SALVIA

62 West 45th Street, 11th Floor
New York, NY 10036
Tel: (212) 246-9800

MEP ENGINEER:

ICOR CONSULTING
ENGINEERS

465C ROUTE 1 SOUTH, SUITE 200
SEELIN, NJ 08830
TEL: 908-272-3300
FAX: 908-272-4440

GEOTECHNICAL ENGINEER:

Langan Engineering

River Drive Center 1
619 River Drive
Briarwood Park, NJ 07407
TEL: (201) 794-6900
FAX: (201) 794-6366

FAÇADE CONSULTANT:

Heintges & Associates

440 Park Avenue South, 15th Fl
New York, NY 10016
TEL: (212) 632-9566

FAÇADE MAINTENANCE:

ENTER

ENGINEERING LLC

166 Ames Street, Hackensack, NJ 07601
Ph: (201) 820-2801 Fax: (201) 820-2804

ELEVATOR CONSULTANT:

Delivering Vertical Transportation
Solutions - Worldwide

27 West 24th Street, Suite 604
New York, NY 10010
TEL: (212) 274-7576

INTERIOR DESIGNER:

SHAMIR SHAH DESIGN

311P GLOBAL GATEWAY TOWER,
63 WING HONG STREET
KOWLOON, HONG KONG
TEL: (852) 2525-2428

INTERIOR DESIGNER:

AB CONCEPT

311P GLOBAL GATEWAY TOWER,
63 WING HONG STREET
KOWLOON, HONG KONG
TEL: (852) 2525-2428

POOL CONSULTANT:

POOL DESIGN

A Division of Lanthrop Associates LLP

333 WESTCHESTER AVENUE
WHITE PLAINS, NY 10604
TEL: (917) 741-1115

LIGHTING DESIGNER:

FOCUS LIGHTING

221 West 16th Street
New York, NY 10011
TEL: (212) 865-1565

LIGHTING DESIGNER:

FILAMENT33 INC

910 GERMANTOWN AVE
PHILADELPHIA, PA 19118
TEL: (484) 674-0133

AUDIO VISUAL & TELECOMMUNICATIONS:

Carani

404 FIFTH AVENUE, 8TH FL
NEW YORK, NY 10018
TEL: (212) 370-1776

DATE: 06/17/2018

ISSUED TO DCR

DATE: 06/17/2018

ISSUED TO DCR

DATE: 06/04/2018

ISSUED TO DCR

DATE: 06/04/2018


ISSUED TO DCR

DATE: 06/04/2018

ISSUED TO DCR

EXISTING MECHANICAL EQUIPMENT LAYOUT ONLY
17TH FLOOR 11-06-2019

EQUIPMENT

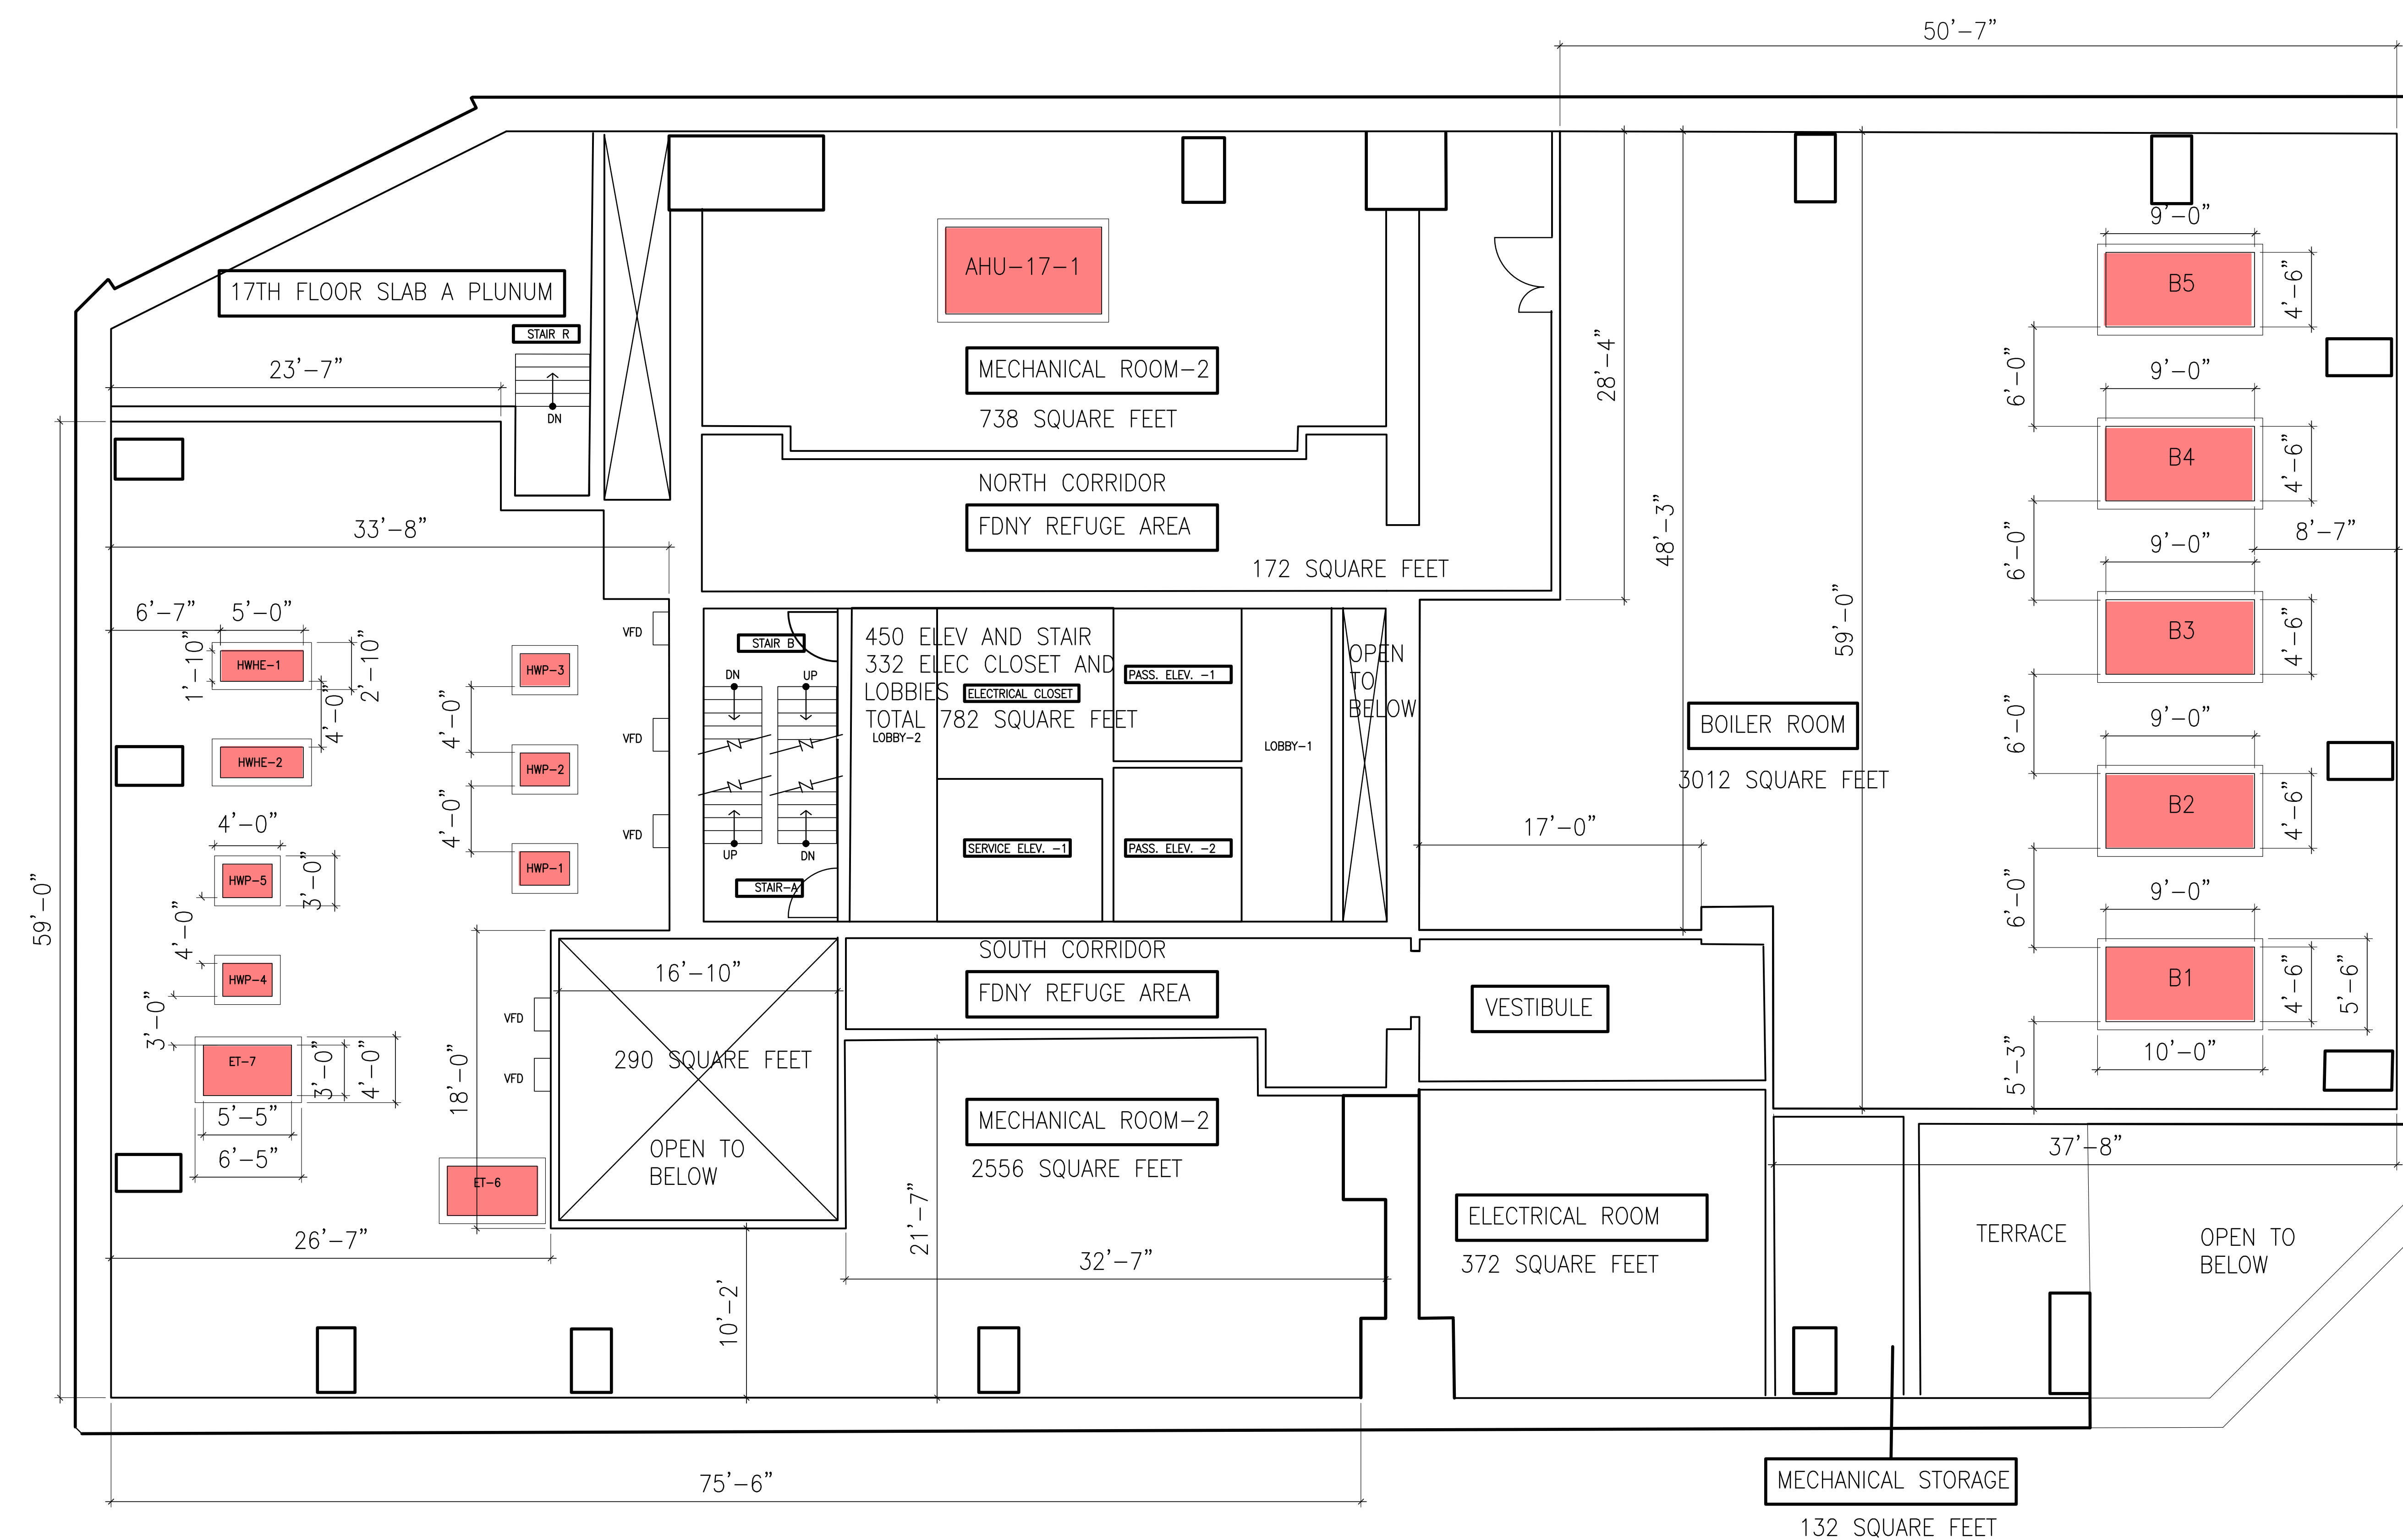

CONSOLIDATED MECHANICAL EQUIPMENT LAYOUT ONLY
17TH FLOOR 11-06-2019

EQUIPMENT

